



100% BID FINAL DOCUMENTS

NTC ORLANDO ARMORY RENOVATIONS CFMO#214001 - ANNEX BUILDING

8385 DAETWYLER DR. ORLANDO, FL 32827

1	1/21/15	PRE-BID ADDEN-2
MARK	DATE	DESCRIPTION
ISSUE:	1/21/2015	
PROJECT NO:	13G0013	
CAD FILE:	NCS Test Project.rvt	
DRAWN BY:	Author	
CHECKED BY:	Checker	
REVIEWED BY:		

© Copyright Hanson Professional Services Inc. 2014


SHEET TITLE
ENLARGED PLANS

A401
SHEET ___ OF __.


PLUMBING FIXTURE LEGEND	
FIXTURE	TYPE
A	4" FLOOR DRAIN W/ STAINLESS STEEL FLOOR DRAIN COVER
B	WALL MOUNTED URINAL (NON-ADA)
C	20" ADA HEIGHT WALL MOUNTED LAVATORY
D	STANDARD FLOOR MOUNTED FLUSH VALVE TOILET
E	ADA FLOOR MOUNTED FLUSH VALVE TOILET
F	ADA HAND SHOWER WAND
G	STAINLESS STEEL SHOWER TRENCH DRAIN COVER. SEE DETAIL 9/A402.
H	SHOWER HEAD (NON-ADA)
J	ADA SHOWER STALL FLOOR DRAIN W/ STAINLESS STEEL FLOOR DRAIN COVER.
K	HI-LOW ADA-COMPLIANT ELECTRIC WATER COOLER
M	WALL-MOUNTED URINAL (ADA HEIGHT - 1'-4" A.F.F.)

RESTROOM ACCESSORY LEGEND			
#	MANUF.	MODEL	TYPE
1	BOBRICK	B-6806	36" AND 42" GRAB BARS
2	BOBRICK	B-3961	RECESSED ADA PAPER TOWEL DISPENSER AND WASTE RECEPTACLE UNIT
3	BOBRICK	B-2111	SURFACE MOUNTED SOAP DISPENSER
7	LOCKER	SEE SPECIFICATIONS	DOUBLE TIER SOLID PHENOLIC LOCKER UNIT. SEE DETAIL 12/A402.
9	BOBRICK	B-6777	WALL MOUNTED TOWEL PIN
10	BOBRICK	B-68137	18" X 38" HORIZONTAL SHOWER GRAB BAR
11	BOBRICK	B-262	SURFACE MOUNT PAPER TOWEL DISPENSER
13	BOBRICK	B-270	SURFACE MOUNT SANITARY NAPKIN DISPOSAL UNIT
14	BOBRICK	B-3706	RECESSED SANITARY NAPKIN DISPENSOR UNIT
15	SHOWER SEAT	SEE SPECIFICATIONS	ADA FOLDING SHOWER SEAT. SEE MOUNTING HEIGHTS
16	BOBRICK	B-292	MIRROR WITH S.S. FRAME AND SHELF
17	BOBRICK	B-2740	SURFACE MOUNT DOUBLE-ROLL TOILET TISSUE DISPENSER
18	BOBRICK	B-680	SURFACE MOUNTED S.S. SOAP DISH
19	BENCH	SEE SPECIFICATIONS	SOLID PHENOLIC LOCKER ROOM BENCH. SEE DETAIL 13/A402.


KEY VALUE	REFERENCE KEYNOTES
A08	SLOPE FINISHED FLOOR SURFACE TO FLOOR DRAIN WITH SLOPE NOT TO EXCEED 2% STEEPNESS.
A44	SLOPE FINISHED FLOOR SURFACE IN SHOWER 1/4" PER FOOT TO DRAIN.

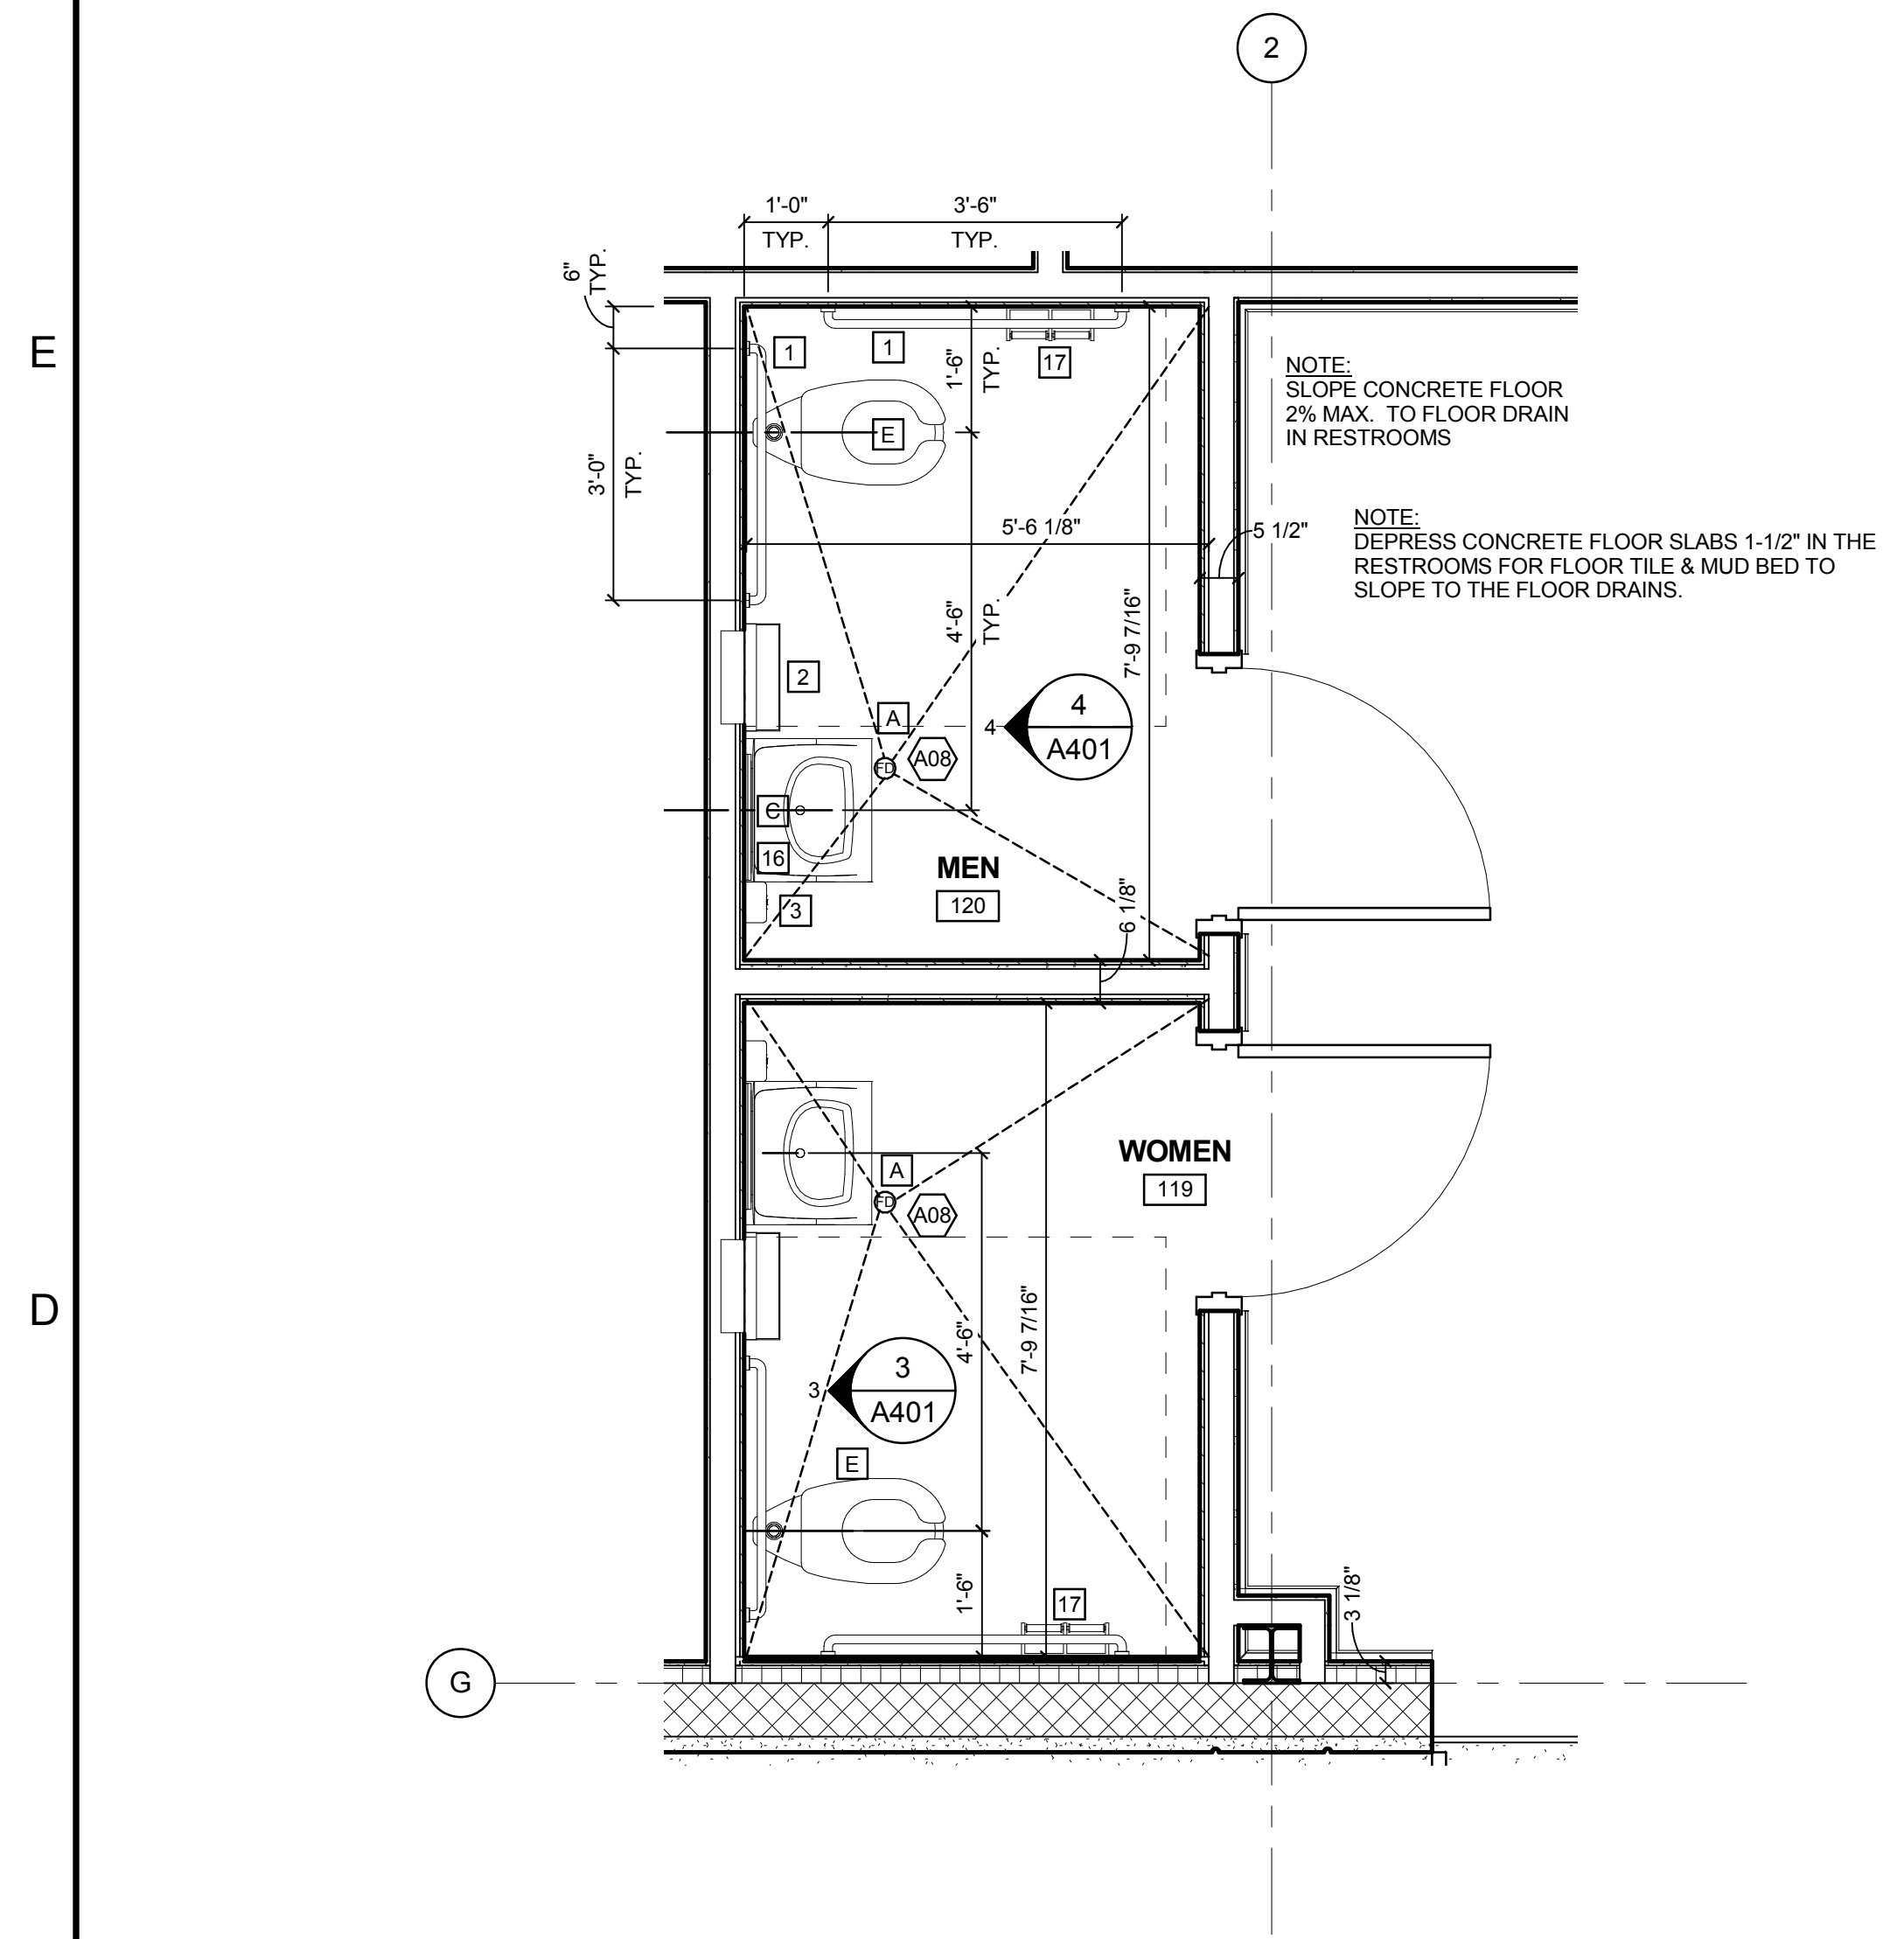


2 ENLARGED VISITOR'S RESTROOMS PLAN
SCALE: 1/2" = 1'-0"

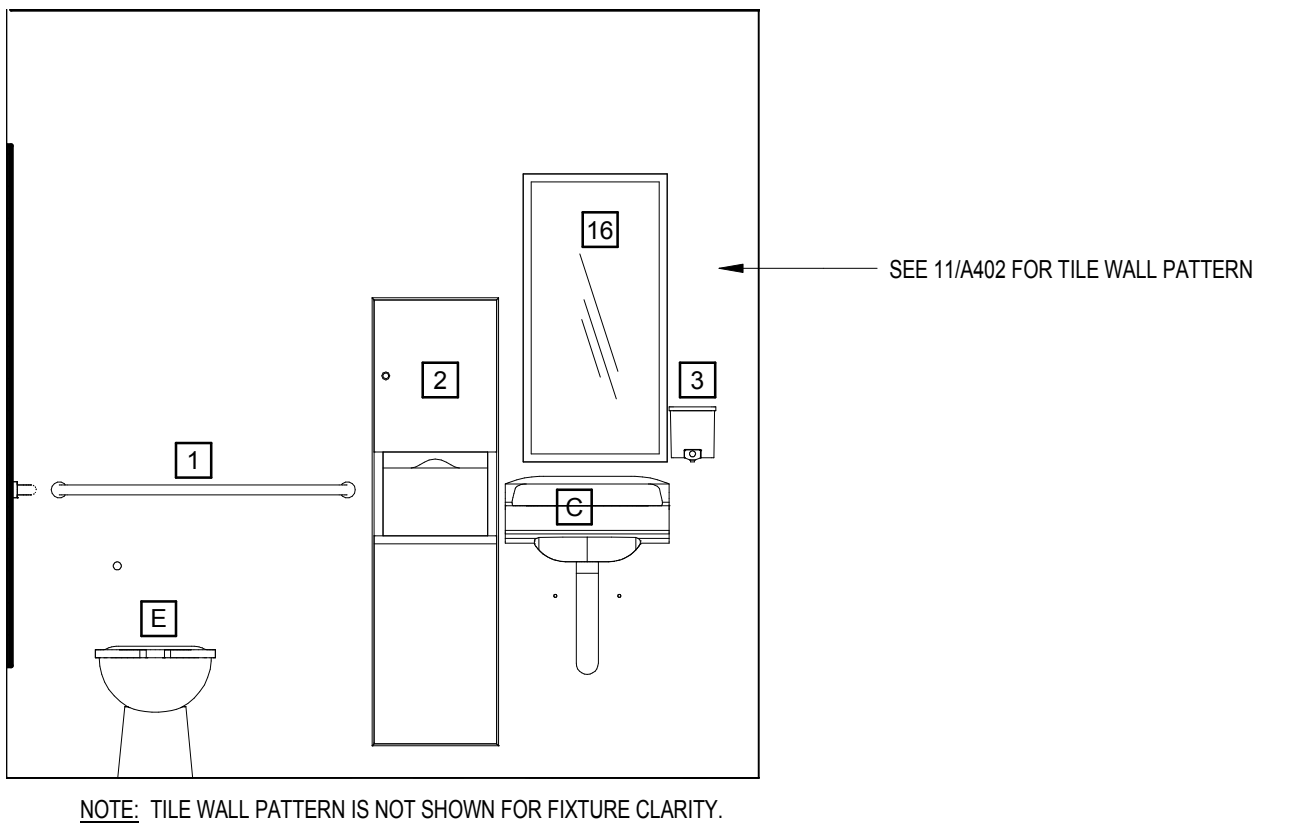

3 WOMEN'S RR-119 WEST ELEV.
SCALE: 1/2" = 1'-0"

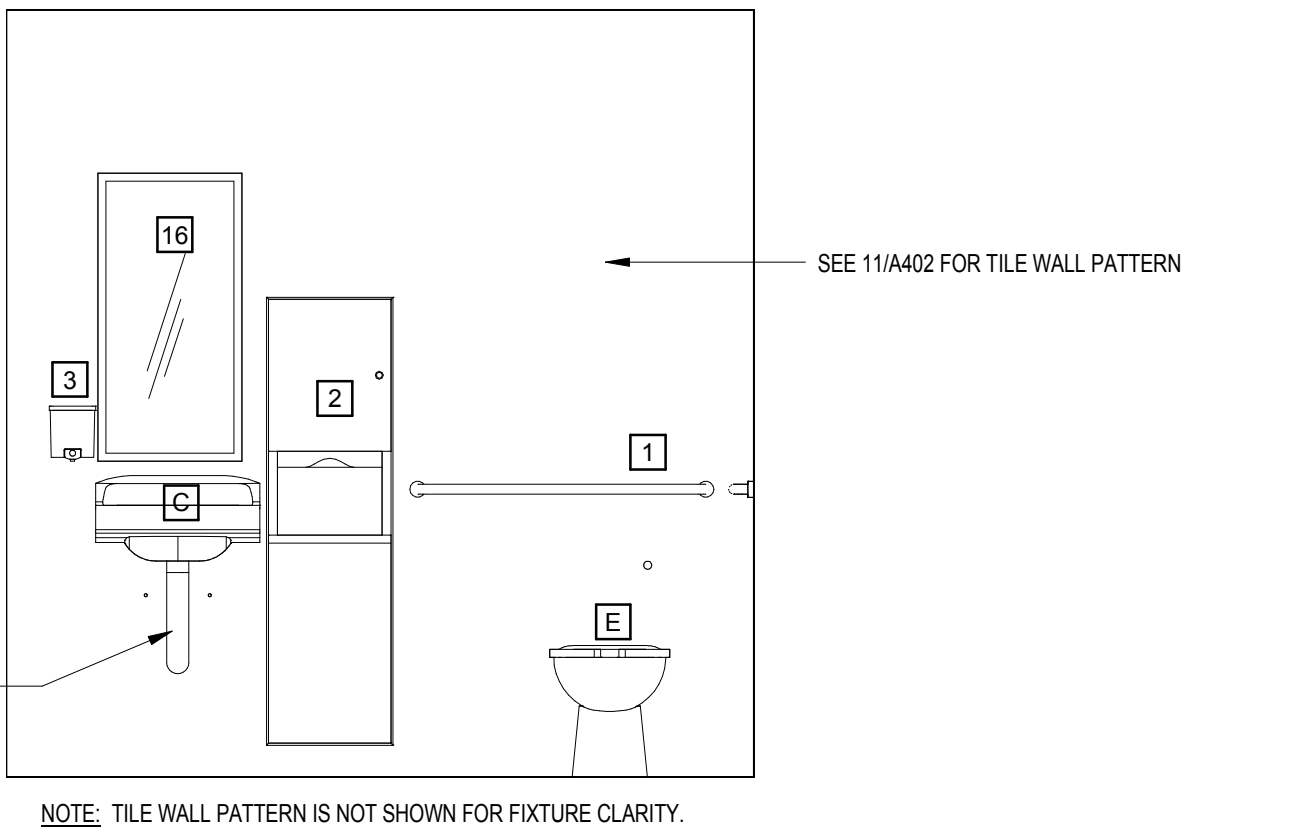

4 MEN'S RR-120 WEST ELEV.
SCALE: 1/2" = 1'-0"

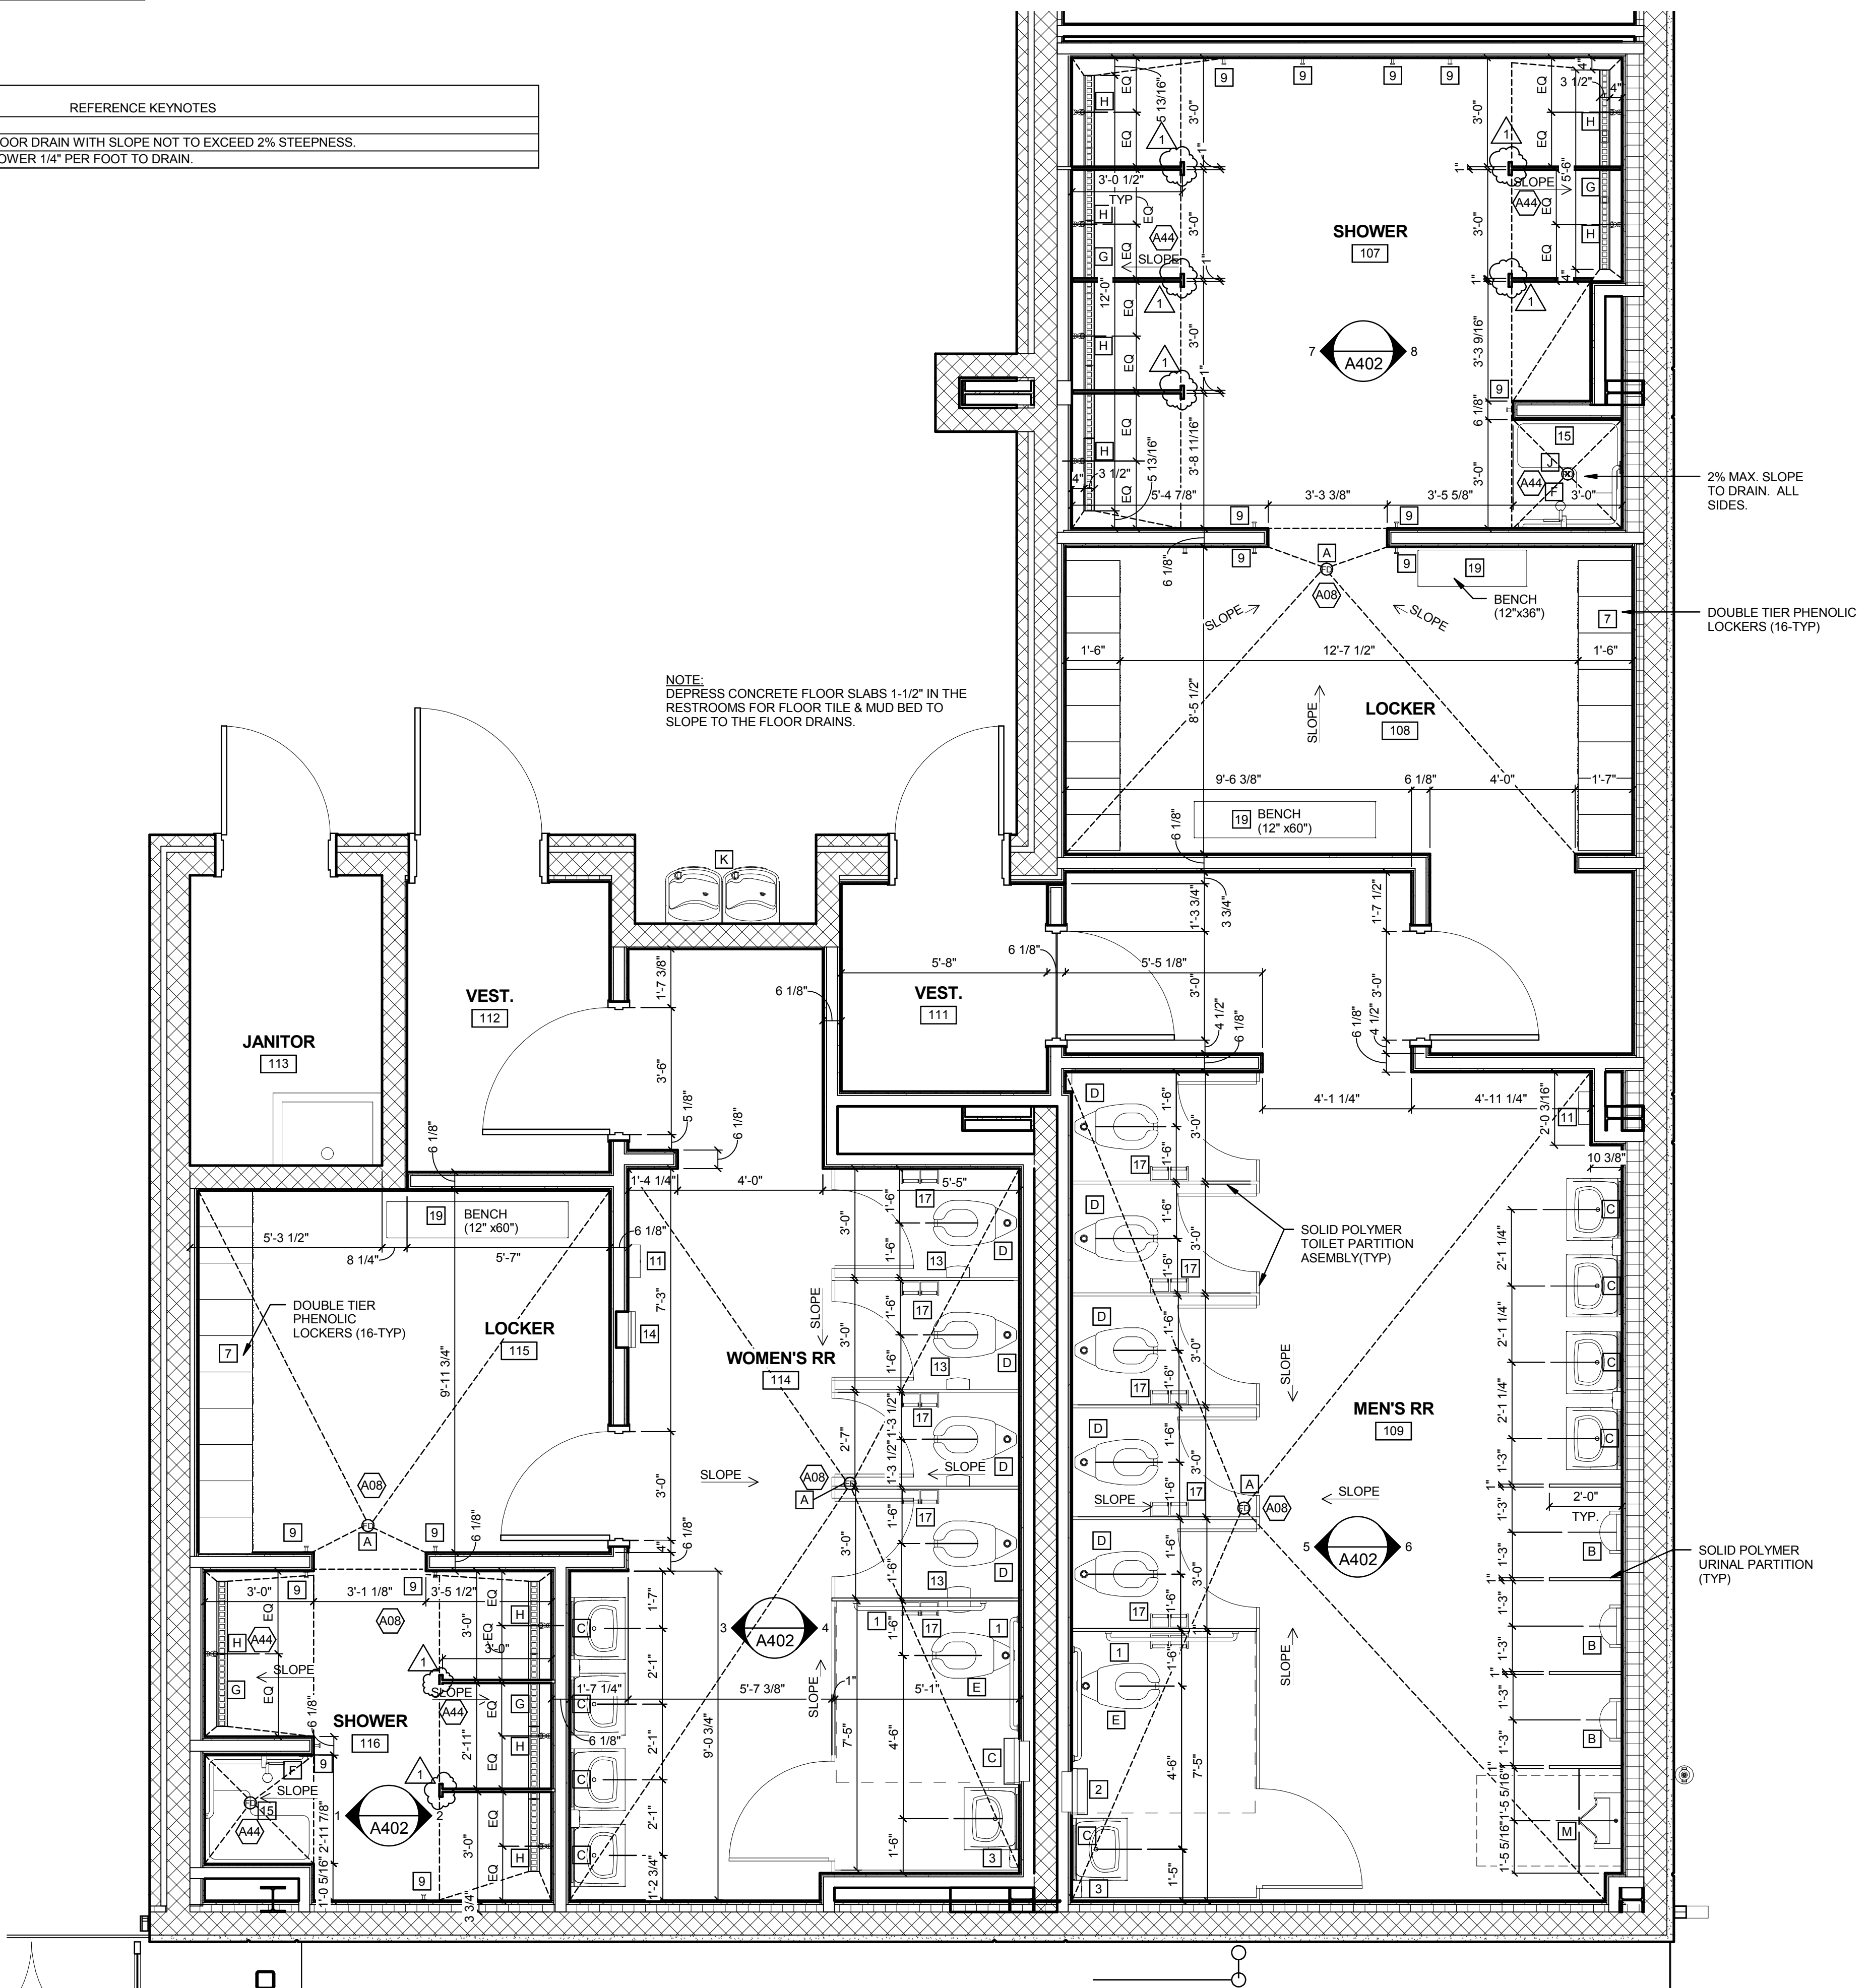

1 ENLARGED RESTROOM PLAN
SCALE: 3/8" = 1'-0"

1/22/2015 10:40:33 AM
C:\WORK\2015\ORLANDO\NCS\ORL13A.rvt